
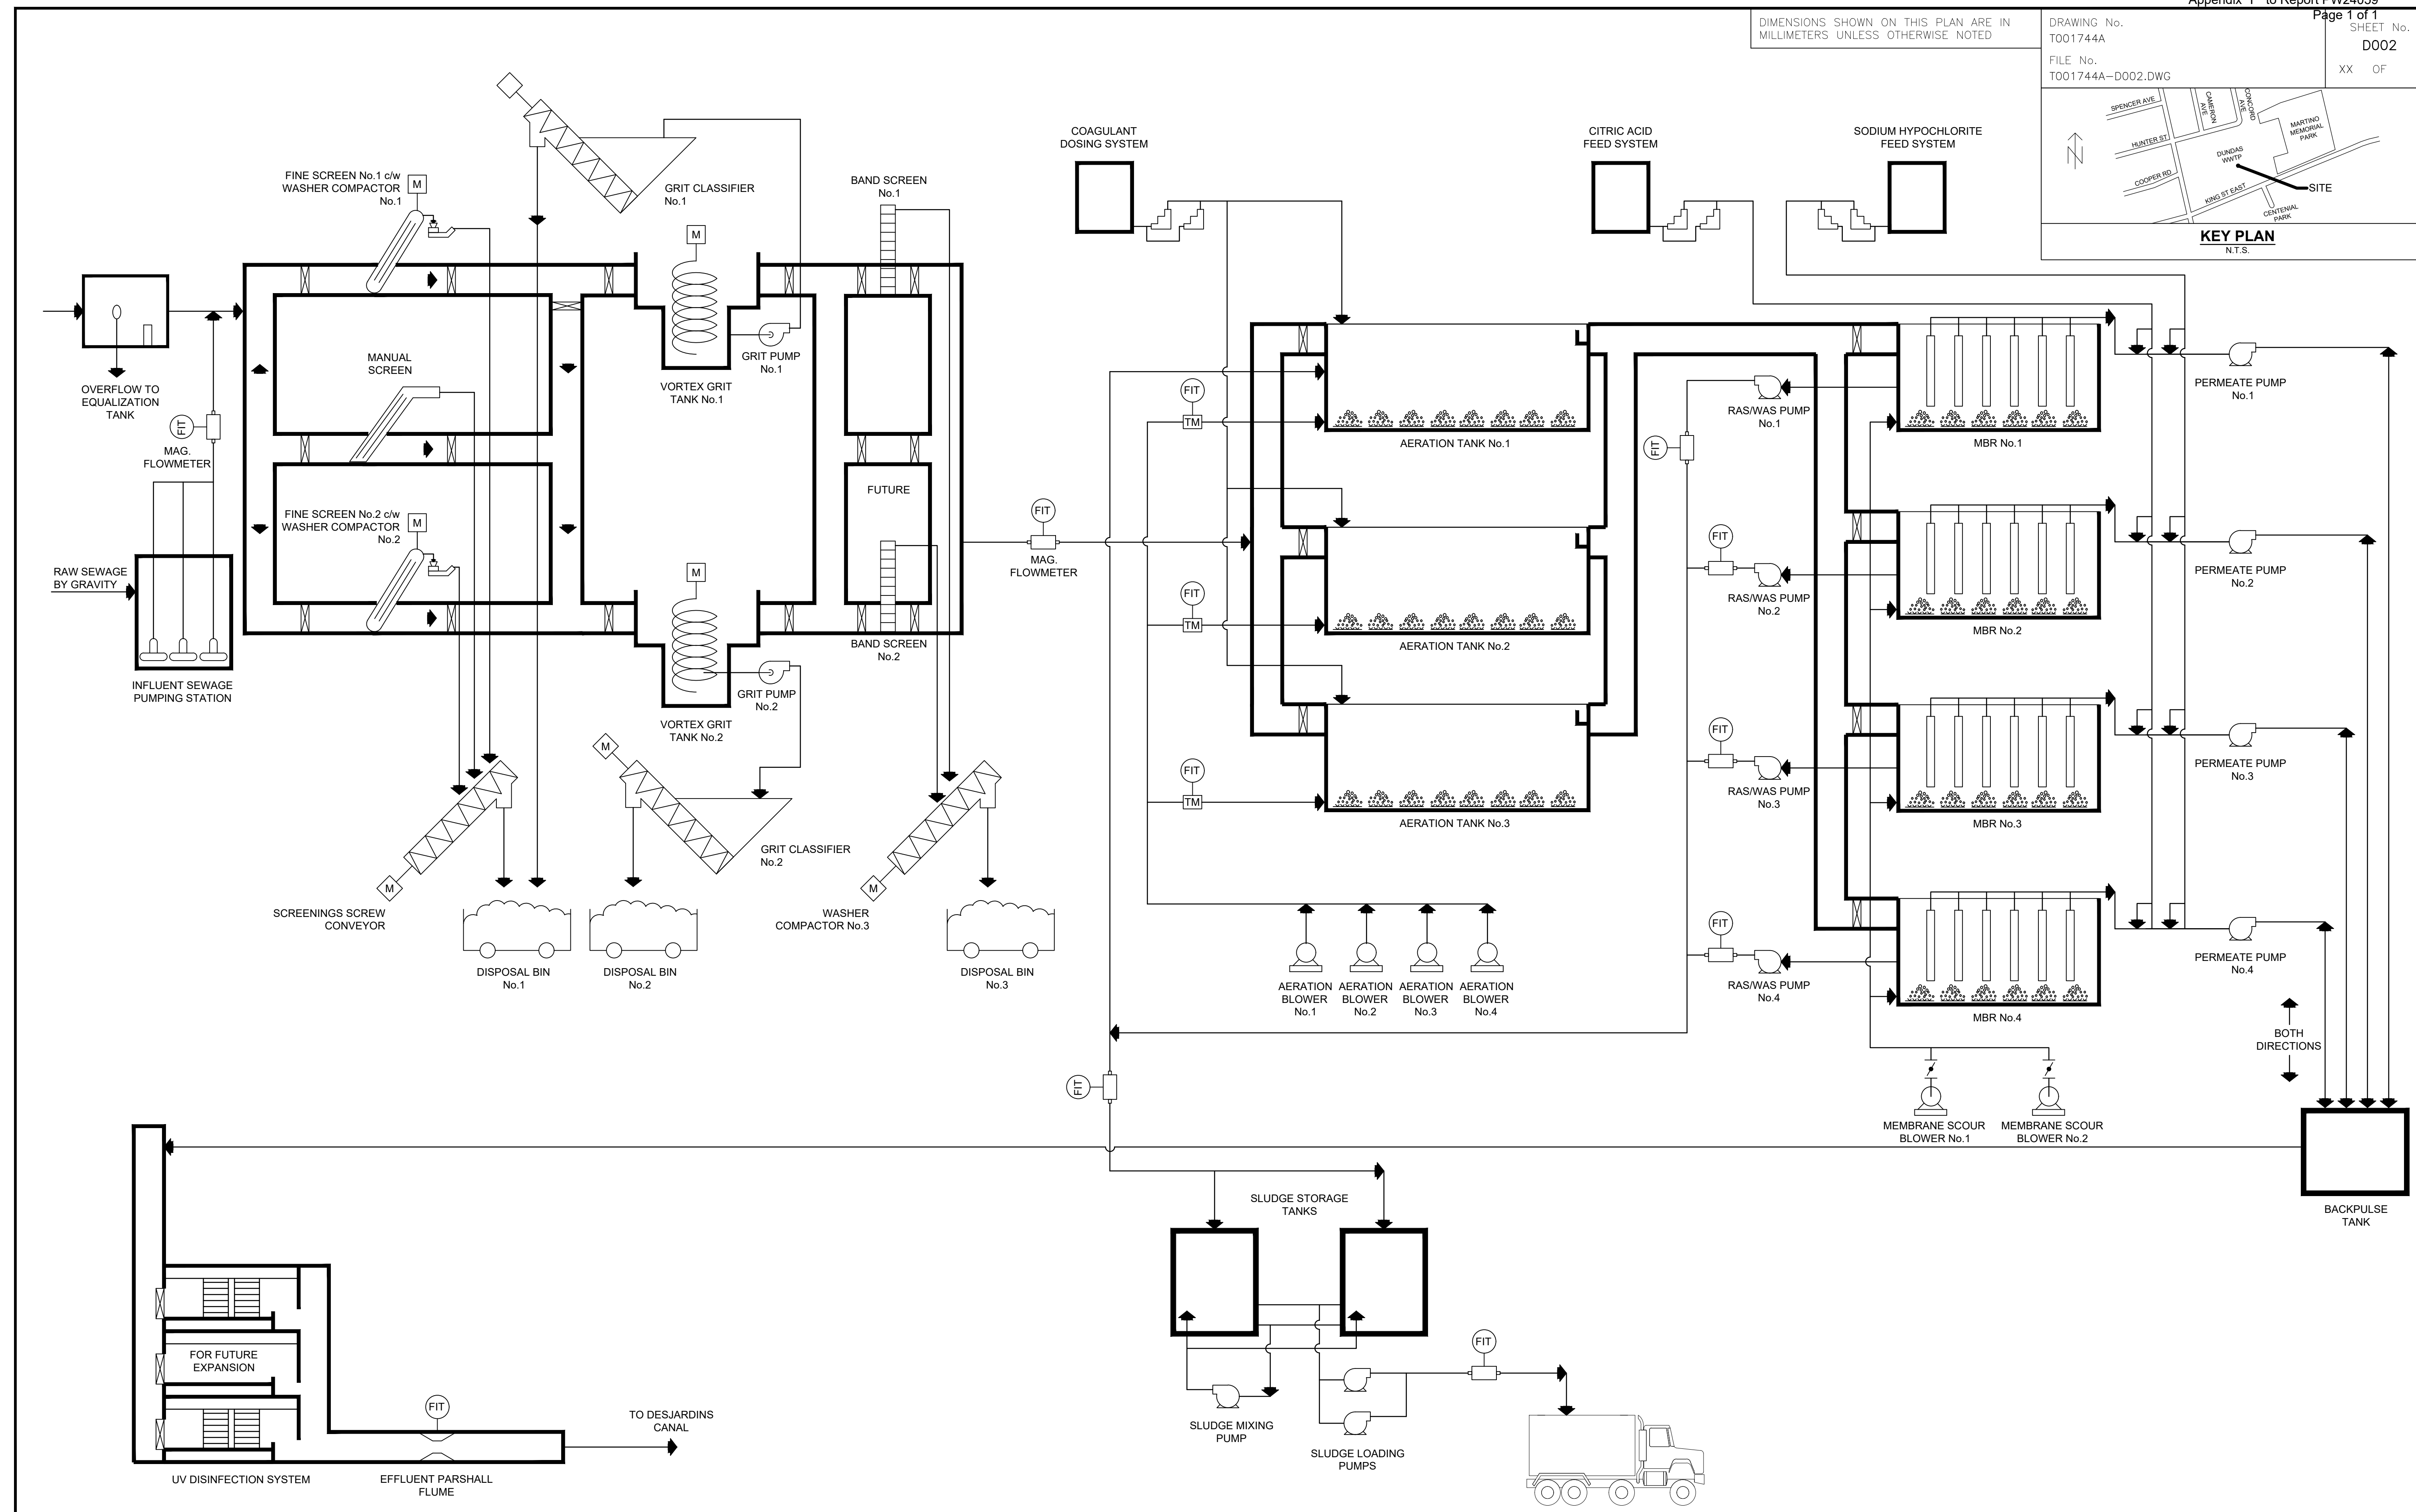


DIMENSIONS SHOWN ON THIS PLAN ARE IN MILLIMETERS UNLESS OTHERWISE NOTED

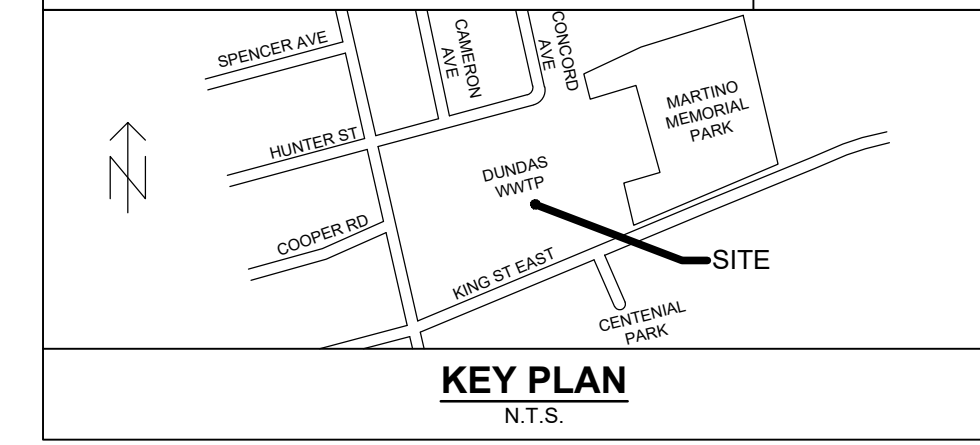

No.	REVISIONS	INITIAL	DATE
A	ISSUED FOR CONCEPTUAL DESIGN	G.A.	JUNE 2024

DRAWN BY: D.C.
 CHECKED BY: K.Y.K.
 APPROVED BY: G.A.

DATE: 29-05-2024
 DATE: 29-05-2024
 DATE: 29-05-2024

Geodetic Bench Mark Index No.
 Elevation=

SCALE
 NTS



CIMA+
 500-5035 AIRPORT ROAD
 MISSISSAUGA, ON L4V 1W5
 T 905.696.1000 F 905.696.0525
 www.cima.ca

CITY OF HAMILTON
 Public Works Department

PROCESS FLOW DIAGRAM
 FACILITY UPGRADE PLAN
 DUNDAS WWT